


North Elevation

West Elevation

East Elevation

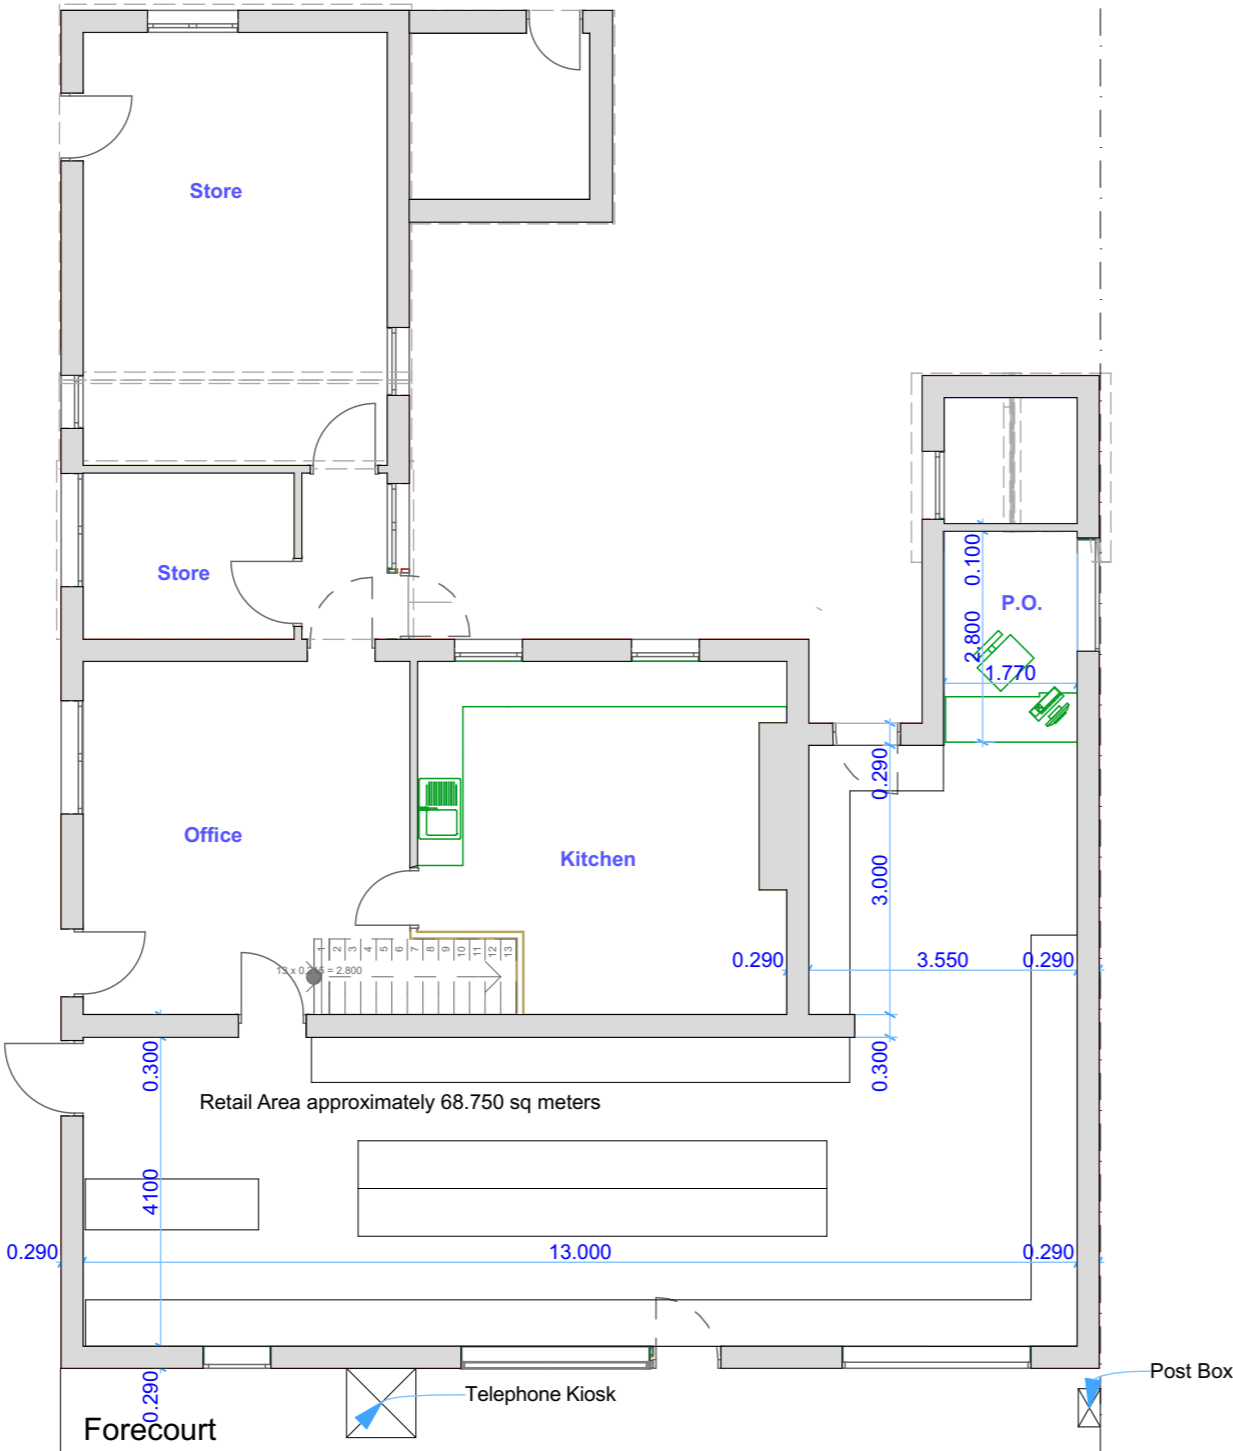

South Elevation

0.

Ground Floor


1:100

The drawing is issued for design purposes only and must not be used for construction. all dimensions are to be checked on site prior to commencement of work or fabrication of components

this drawing is issued subject to a detailed structural survey, soil tests, local authority planning approval and building regulations

heating or lighting layouts are intended as a general guide only and will be subject to a final design by the relevant engineer or contractor. all works shall comply with the relevant building regulations

this drawing is copyrite of The Design Partnership at the address shown and may not be reproduced, used, stored or transmitted by any means, electronic, mechanical, photocopying or otherwise without prior permission.

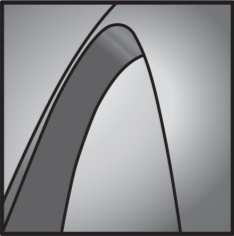Revision History	
The Design Partnership	
	
The Design Partnership	
Halbury House Much Birch Herefordshire HR2 8HJ Phone 01981 540234 Mob 07403313016 Email bdphalpin@live.co.uk	
New Housing & Shop	
Parminder Singh & Kulwant Kaur Peterstow Stores Peterstow Herefordshire HR9 6LB	
Planning Drawings	
Ground Floor Existing Shop and Flat over	
Modified by BDPH	Date 22/12/2017
Checked by BDPH	Date 22/12/2017
Drawing Scale 1:500	
Layout ID PS/BDH/17/19	Revision 08