


Calculation based on standard reflectance's.
Room/external area dimensions issued from customer.
Ceiling heights assumed @2.5m unless advised otherwise.
PLEASE NOTE: All room/external area dimensions to be checked on-site prior to installation.
PLEASE NOTE: IT IS THE RESONSIBILITY OF THE CONTRACTOR/INSTALLER TO CHECK ALL ROOM/EXTERNAL AREA DIMENSIONS ON-SITE PRIOR TO INSTALLATION.
Lighting designed to CIBSE guidelines where applicable and/or client requirements, all stated lux values are for overall averages across the room reference plane.
If dimmable luminaires have been specified, then it is the responsibility of the contractor to establish which dimming ballasts/system is required by the lighting control ethos/specification.
Lighting designed to issued lighting layout to establish projected light levels meet criteria.

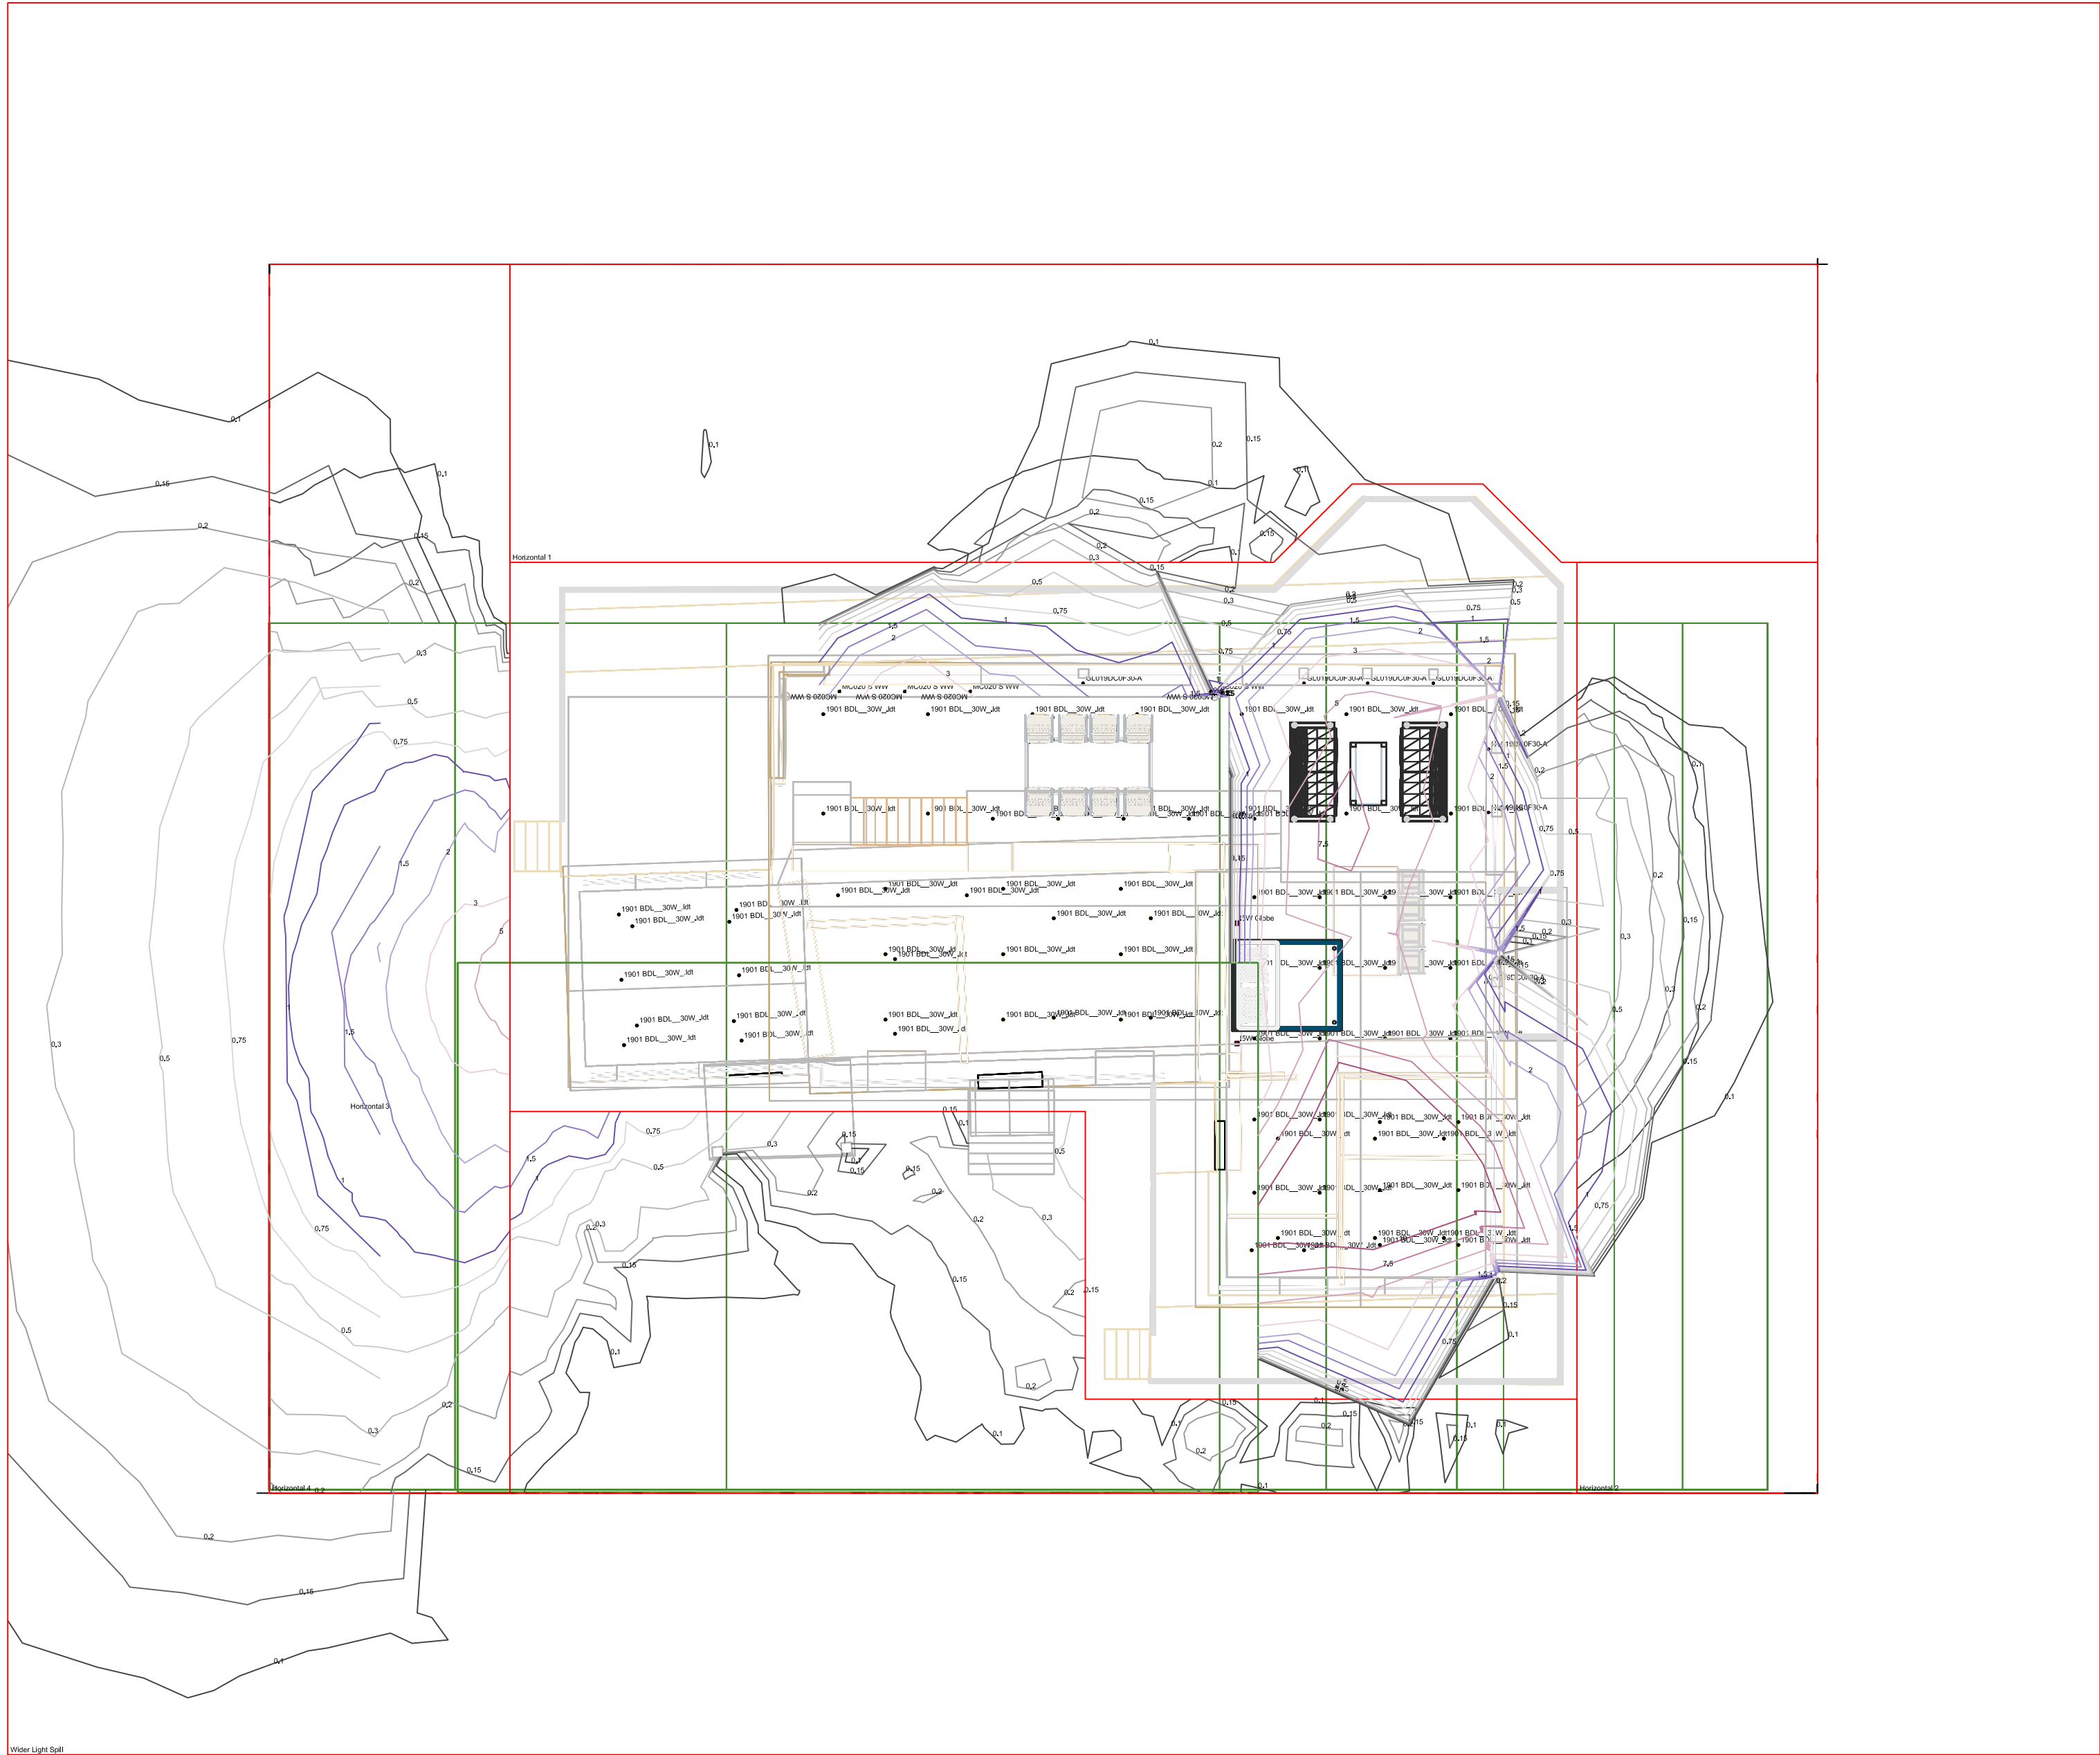

Symbol	Qty	Room Number	Room Name
1	1	1001 BCL_300V_48	1001 BCL_300V_48
2	1	1001 BCL_300V_48	1001 BCL_300V_48
3	1	1001 BCL_300V_48	1001 BCL_300V_48
4	1	1001 BCL_300V_48	1001 BCL_300V_48
5	1	1001 BCL_300V_48	1001 BCL_300V_48



Scale
1:100 @ A1

Project Name, Address & Number
Bridge Cottage
Internals Only

Original Designer IJF	Checked by
Date 19-10-2022	Drawing Number IJF01421-R1 - Internals