


CE08/1031/F

**BLOCK PLAN
(As Proposed)
1/100**

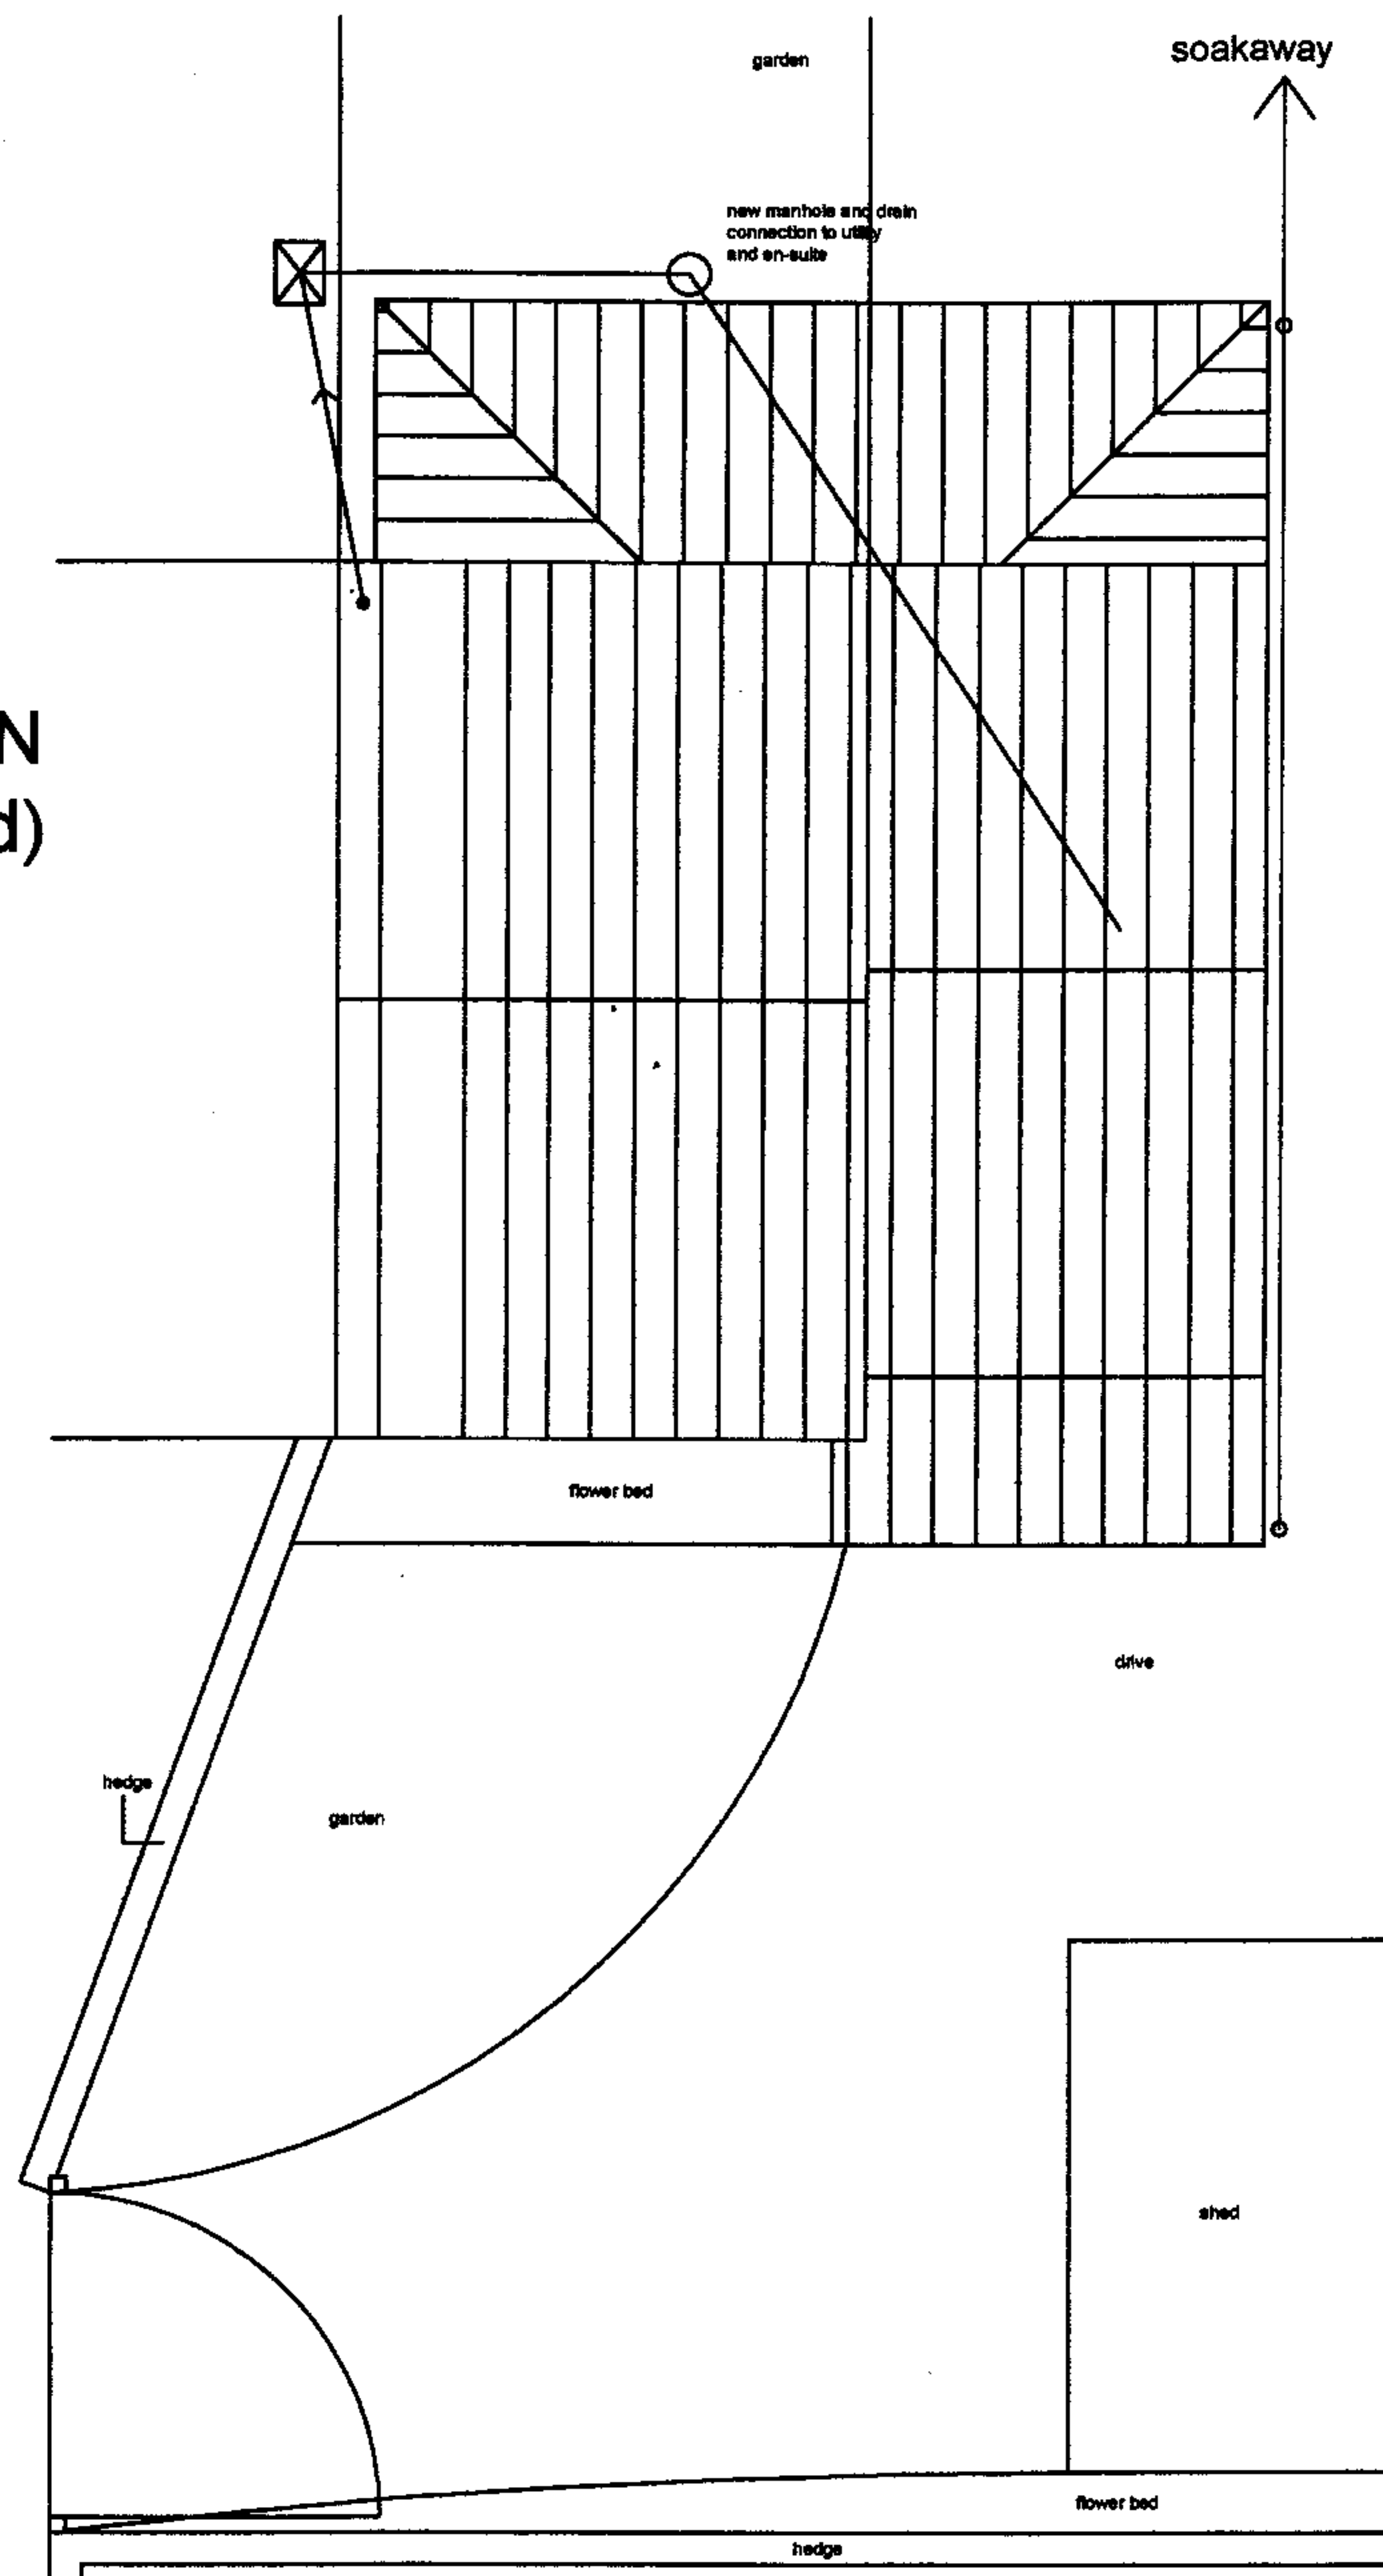

CLIENT
MR & MRS HOSKINS

DRAWING TITLE
DRAINAGE LAYOUT.

DATE
NOVEMBER 2007.

PROJECT TITLE
SIDE & REAR EXTENSION, 8 HOPTON CLOSE,
BARTESTREE, HEREFORDSHIRE, HR1 4DQ.

DRAWING NUMBER
414/011.

SCALE
1/100.

NOTES
Do not scale from drawing and check all
dimensions before carrying out work. Site
conditions and manufacturers requirements
may necessitate changes to dimensions.

HEREFORDSHIRE COUNTY COUNCIL PLANNING SERVICES DEVELOPMENT CONTROL	
4 - APR 2008	
To:	File:
Arch:	File:



John Parry Design Limited
ARCHITECTURE, PLANNING & SURVEYING.

BROADHEATH, MORETON ON LUGG, HEREFORDSHIRE, HR4 8DQ
Tel: 01432 781071