



NORTH

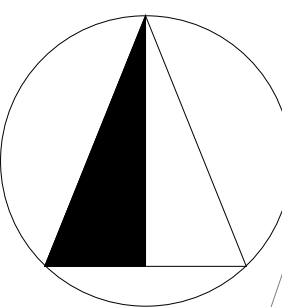

GLAMPitect

W: WWW.GLAMPITECT.CO.UK
E: CONTACT@GLAMPITECT.CO.UK
T: 0131 2029 002

KEY TO SYMBOLS

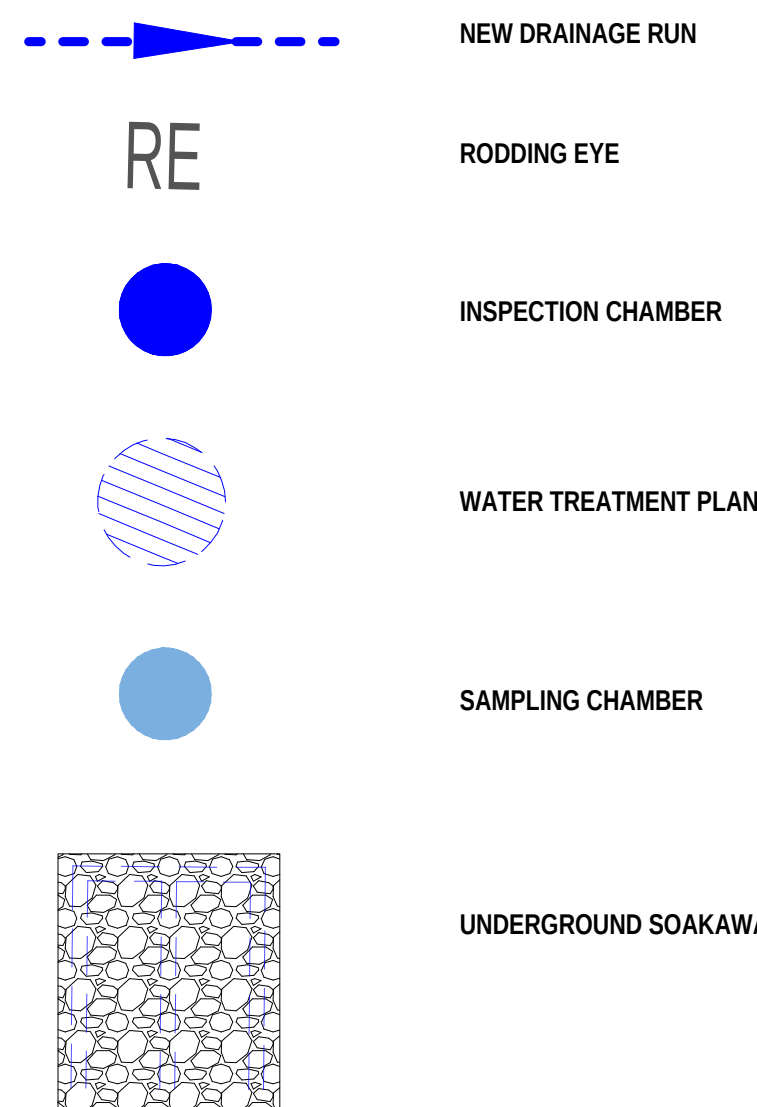


DRAINAGE NOTES

- FALLS FOR FOUL WATER: 1:10 MAX FALL, 1:60 MIN FALL.
- ALLOW FOR NEW SINGLE PHASE POWER SUPPLY TO TREATMENT PLANT. CABLES TO BE A MINIMUM OF 600mm BELOW FINISHED GROUND LEVEL IN UPVC DUCTING WITH WARNING TAPE OVER.
- POWER SUPPLY TO BE SPECIFIED BY THE ELECTRICAL SUB-CONTRACTOR.

All works to be carried out in accordance with the following:-
1. UK water industry research Ltd. 'Civil Engineering Specification for the water industry, 5th Edition.
2. Building Regulations Section 'H'
3. BE EN 752 Drain and Sewers Systems outside buildings.
Foul Water: Falls in runs - 1:10 max - 1:60 min.
All new drainage branches to be swept in direction of flow.
All new drainage branches to be fitted with a RE.
SUDS
All parking areas are to be constructed with a porous build up on free draining

03.09.21	Blue line boundary updated	C	CW
27.08.21	Red line boundary updated	B	CW
09.07.21	Updated scale bar, requested by planner.	A	TA
Date	Description	Rev	By

Revision Description

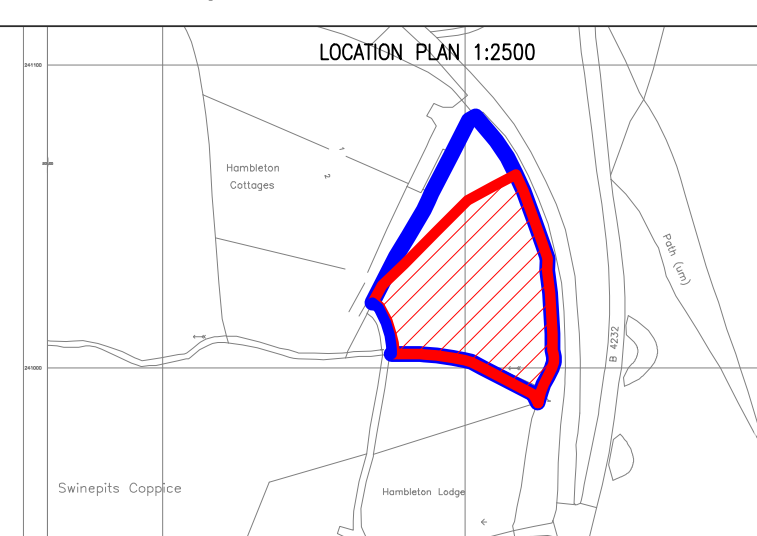

Project:
Hambleton Meadows - Jonathan Aspinall
Hambleton Meadows, Evendine Lane, Colwall
WR13 6DP


Drawing Title:
Drainage Plan

Drawing Number:
200907-01-03



Revision: C
Date: 09.07.21
Scale: 1:100 unless stated otherwise @ A1
Drawn By: TA
CAD Dwg File:
Arch. Base Dwg:

Issue Status:
Planning Application

SCALE BAR 1:100

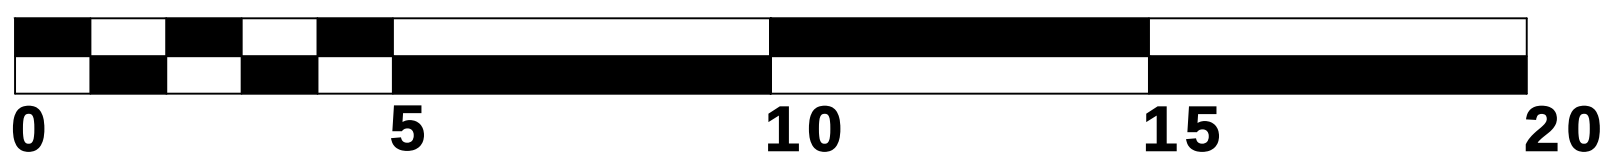

SCALE BAR 1:500

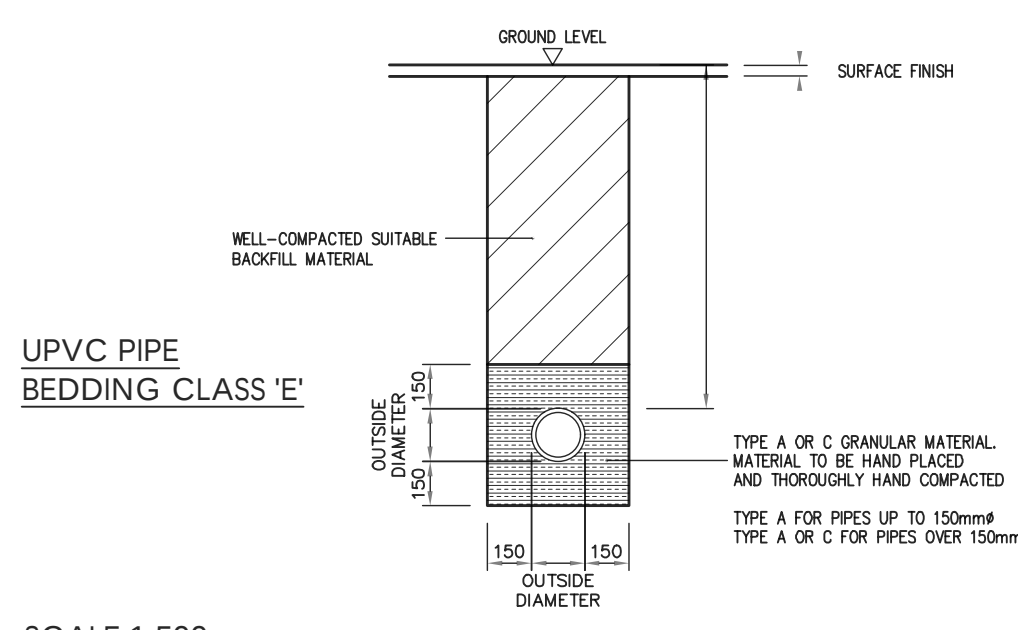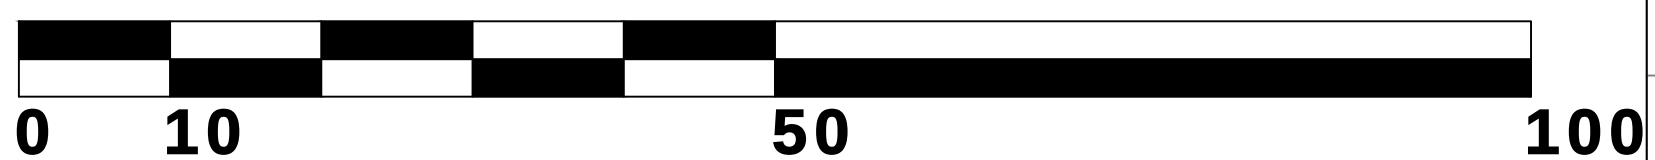

SCALE 1:500

