


LEGEND	
SYMBOL	DESCRIPTION
	MAIN/EMERGENCY EXTERNAL LUMINAIRE (WALL MOUNTED) WHITECROFT 350 CENTURION C/W HOOD AND BAR 25w PLC
	WHITECROFT 70w CDM1 MISTRAL ROAD LANTERN MOUNTED ON 5m COLUMN
	WHITECROFT BROADWALK 42w PLC BOLLARD

- NOTES
- THIS DRAWING IS TO BE READ IN CONJUNCTION WITH ALL RELEVANT ARCHITECTURAL & STRUCTURAL DRAWINGS.
 - THIS DRAWING IS TO BE READ IN CONJUNCTION WITH ALL RELEVANT BUILDING SERVICES DRAWINGS & THE RELEVANT SECTIONS OF THE SPECIFICATIONS & SCHEDULES.
 - THIS DRAWING IS NOT TO BE SCALED.
 - ALL DIMENSIONS ARE IN mm UNLESS OTHERWISE STATED.
 - BASED ON THE FOLLOWING DRAWINGS:
ARCHITECTS - 08-113-110 REV C, 08-113-120 REV C
 - WIRING TO EXTERNAL LIGHTING NOT SHOWN, TO BE DESIGNED BY SUB-CONTRACTOR.
 - EXTERNAL LIGHTING TO BE CONTROLLED BY PHOTOCELL TIMESWITCH WITH OVERRIDE SWITCH IN NURSE BASE/OFFICE.
 - ALL LUMINAIRES TO BE AS STATED, OR SIMILAR APPROVED.

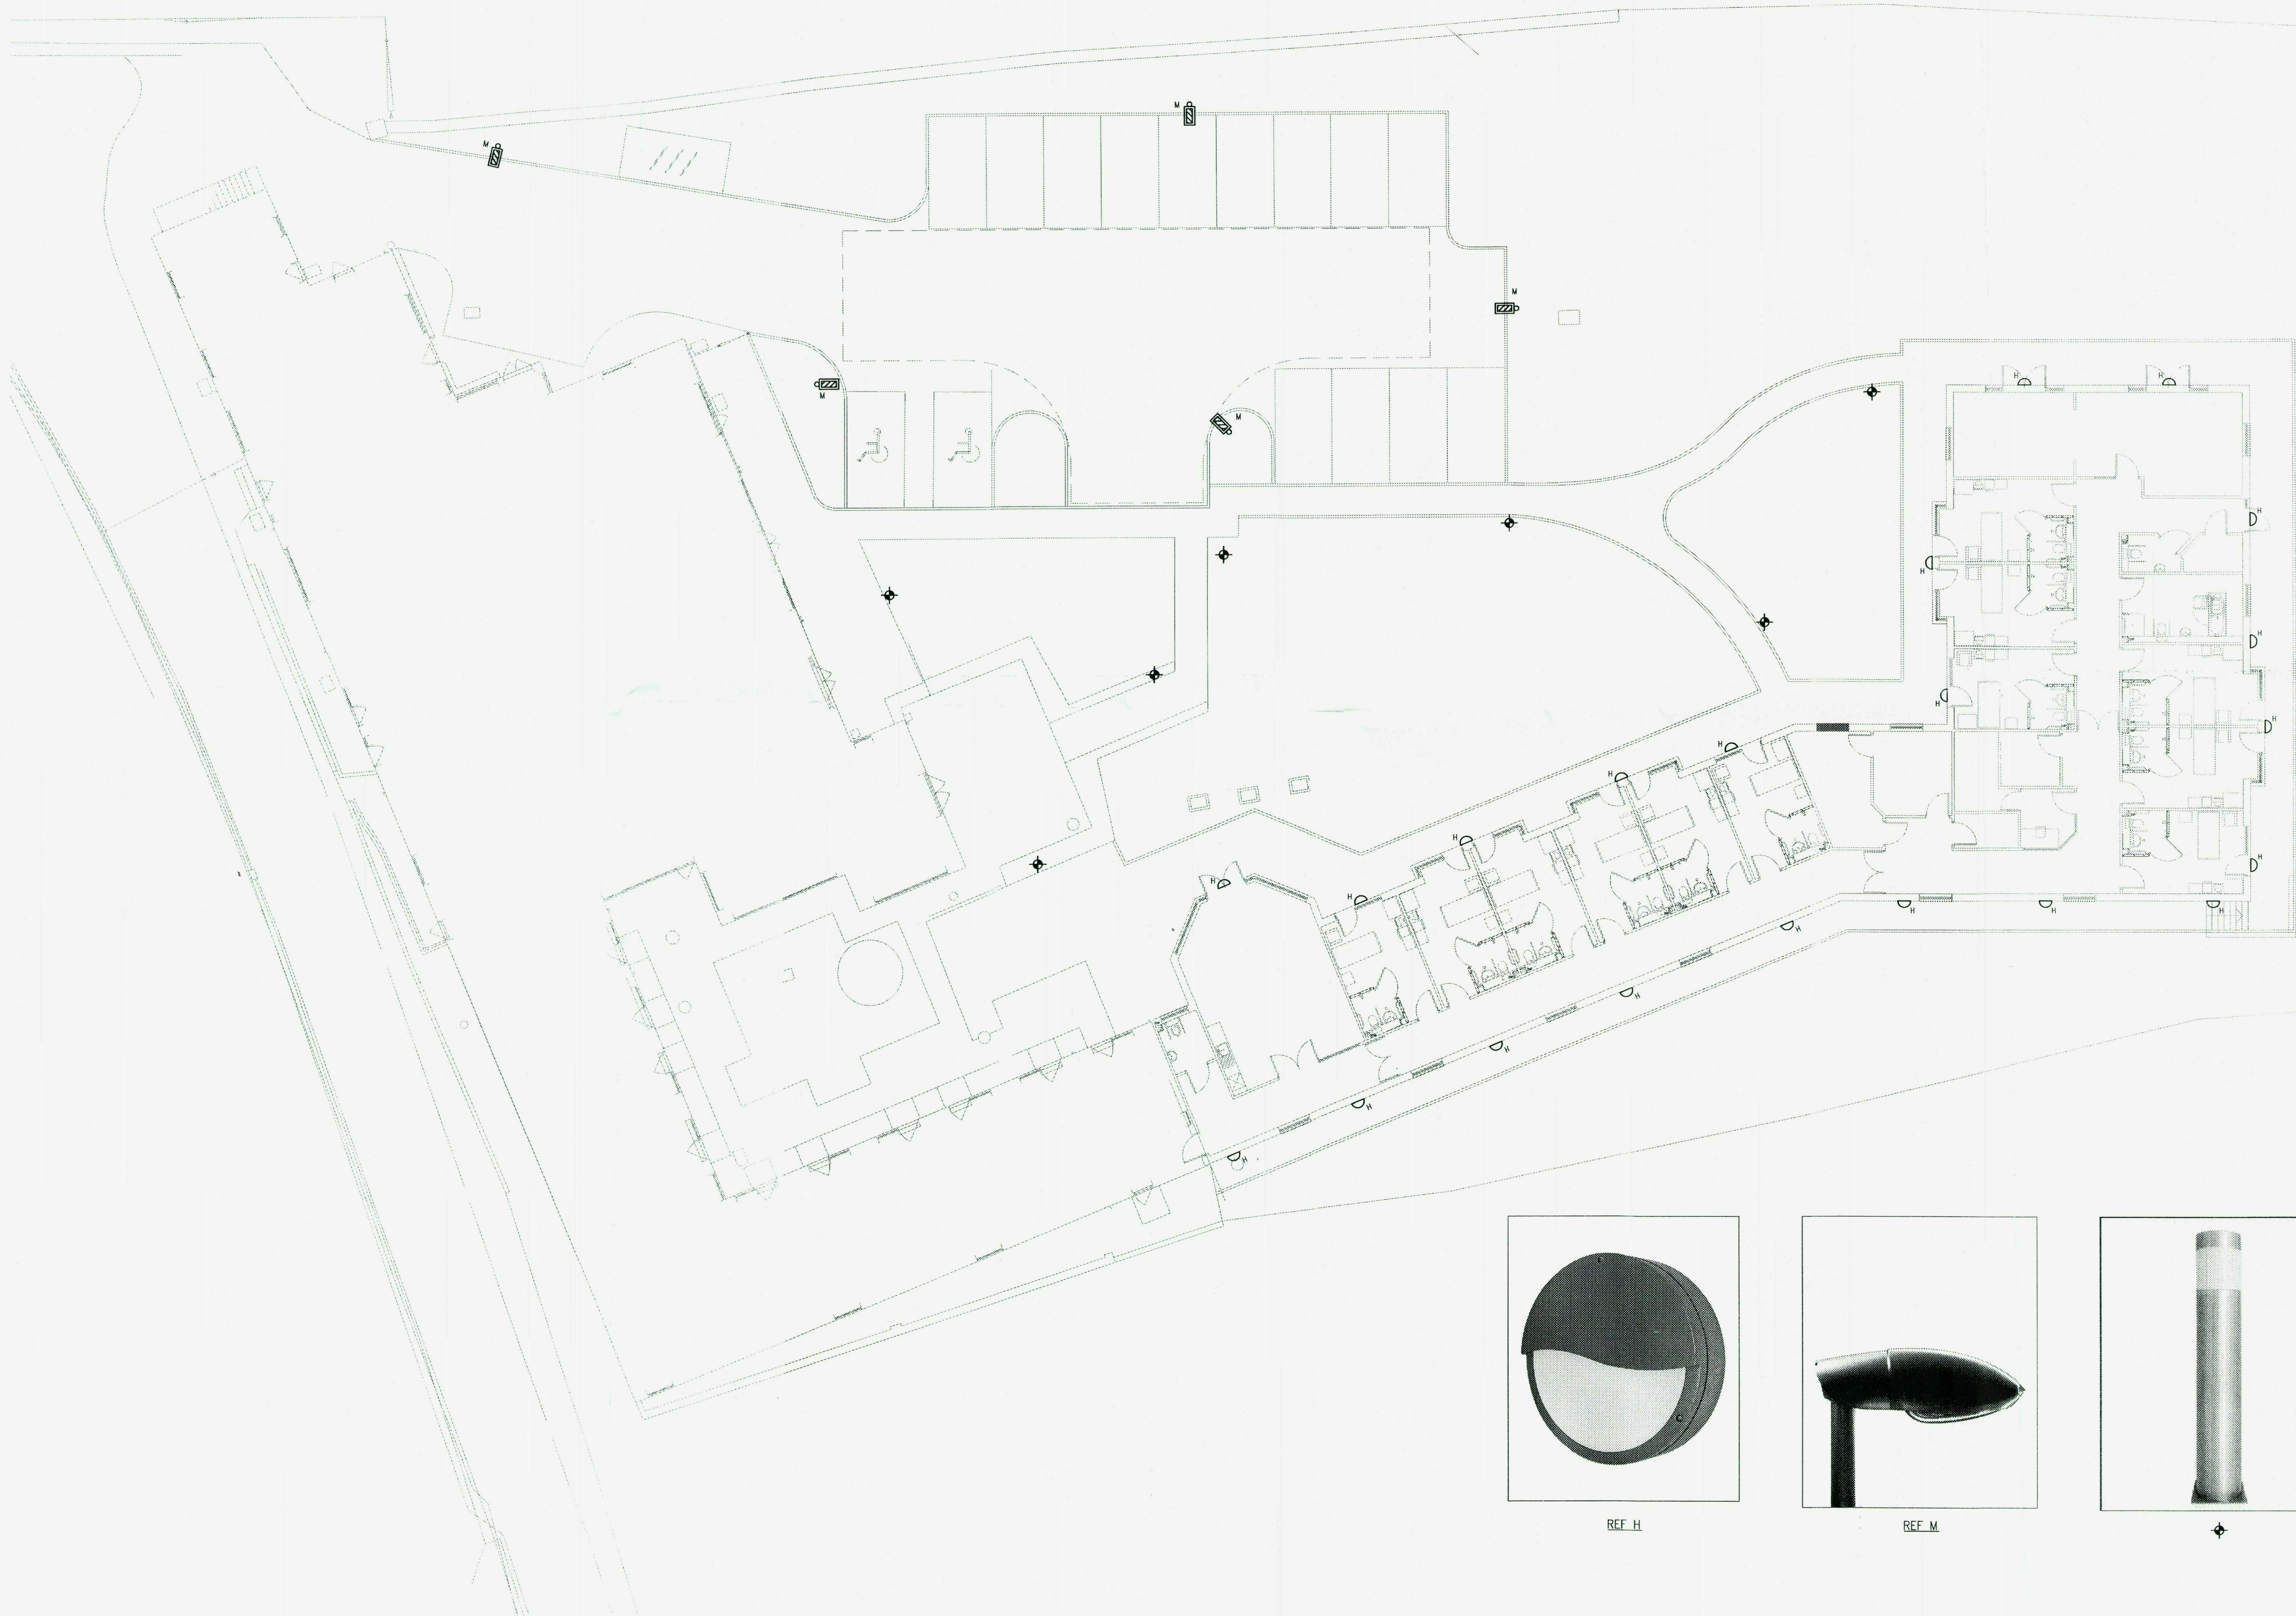

REV	DATE	DESCRIPTION	BY
T1	25.04.12	TENDER ISSUE	CJO

Building Services Design
Consulting Engineers

☐ 1 Blenheim House, Corbygate Business Park
Ripon Road, Corby, Northamptonshire NN17 5JG
Tel: (01536) 403304, Fax: (01536) 403638
E-mail: corby@buildingservicesdesign.co.uk

☐ 87A Worship Street, London, EC2A 2BE
Tel: (0207) 377 9007, Fax: (0207) 377 9111
E-mail: london@buildingservicesdesign.co.uk

☐ Slow Court, Slow Road, Slow-cum-Qui
Cambridge CB2 9AS
Tel: (01223) 815438, Fax: (01223) 812485
E-mail: cambridge@buildingservicesdesign.co.uk

☐ Suite 420, Fort Dunlop, Fort Parkway
Birmingham, B24 9FD
Tel: (0121) 7463 309, Fax: (0121) 7477 398
E-mail: birmingham@buildingservicesdesign.co.uk

☒ 2nd Floor, The Dock Office, Trafford Road,
Salford Quays, Salford, M50 3UB
Tel: (0161) 872 8383, Fax: (0161) 877 3185
E-mail: manchester@buildingservicesdesign.co.uk

QA
SV
100% TESTED
100% SAVED

Client:
ASHBERRY HEALTHCARE LTD

Project:
HOLMER COURT

Title:
**ELECTRICAL SERVICES
SITE PLAN
EXTERNAL LIGHTING LAYOUT**

Scale of A0 Date:	Designed	Drawn	Design:
1:100 APR 12	JEK	CJO	CAD:
Drawing No:	Rev:		
120185/E/2201	T1		

TENDER