


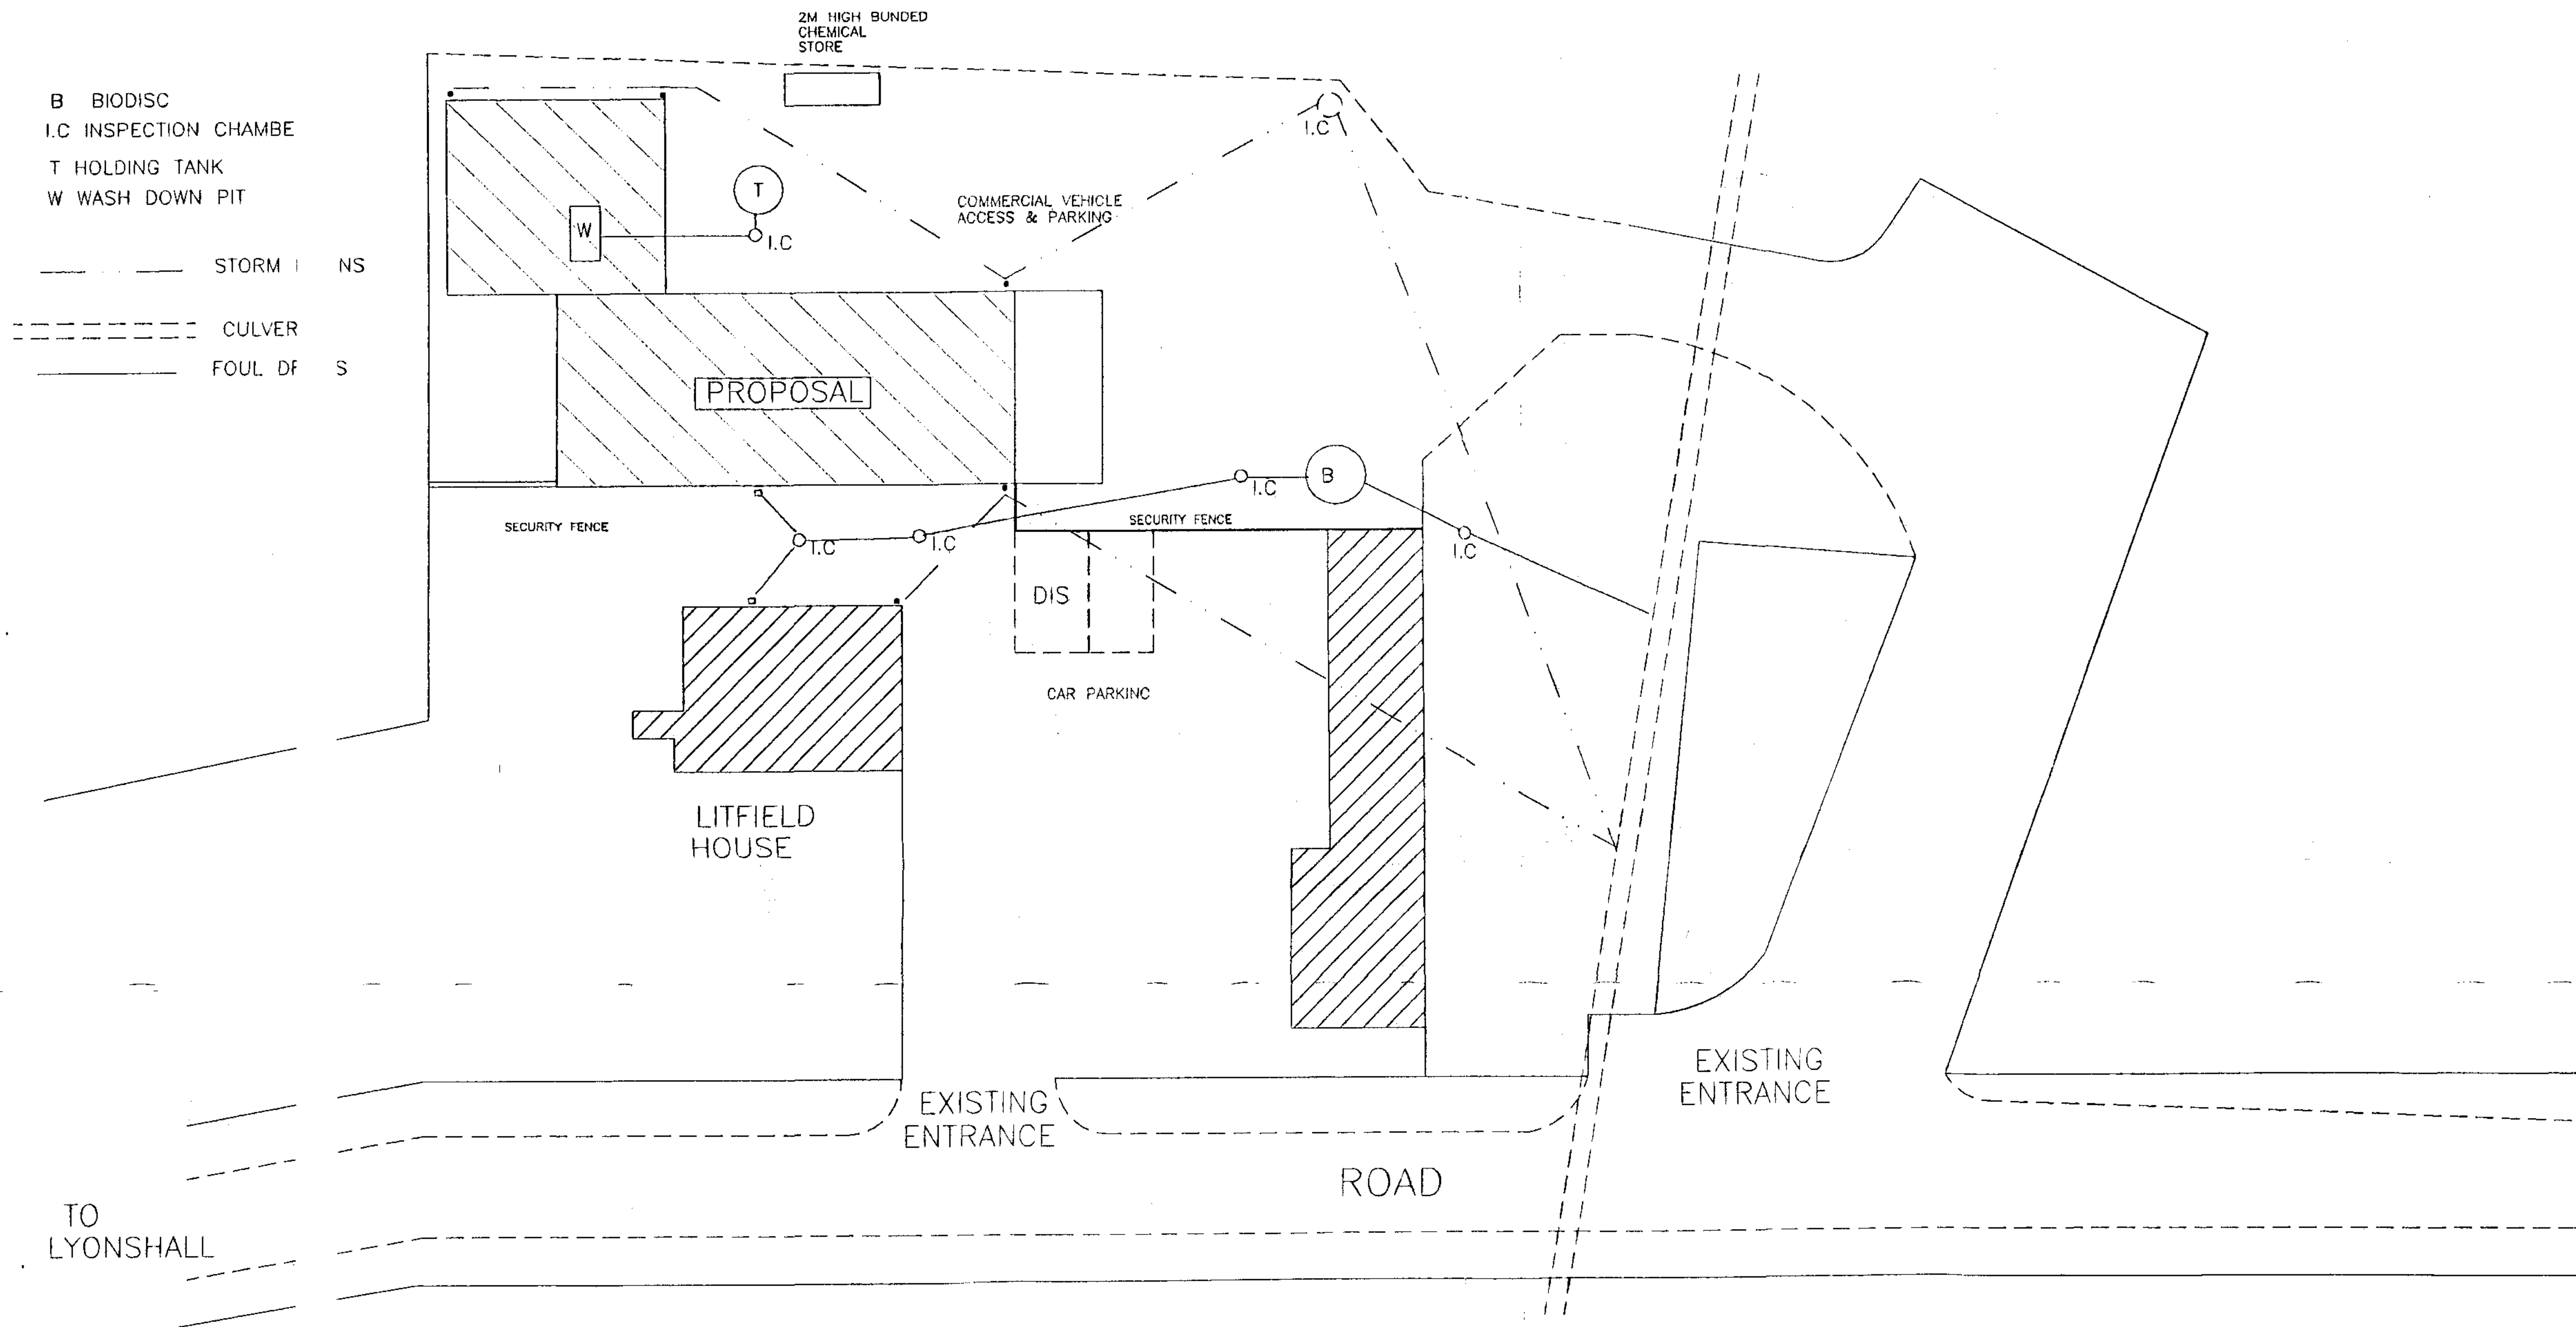

SITE PLAN
SCALE 1:500

DRAINAGE PLAN
ANIMAL FUNERAL SERVICES
LITFIELD HOUSE
LYONSHALL

Drawn By Ian Se
Date 26/07/08
Scale 1:250

HERC
21 JUL 2008
To
Ackd
File