


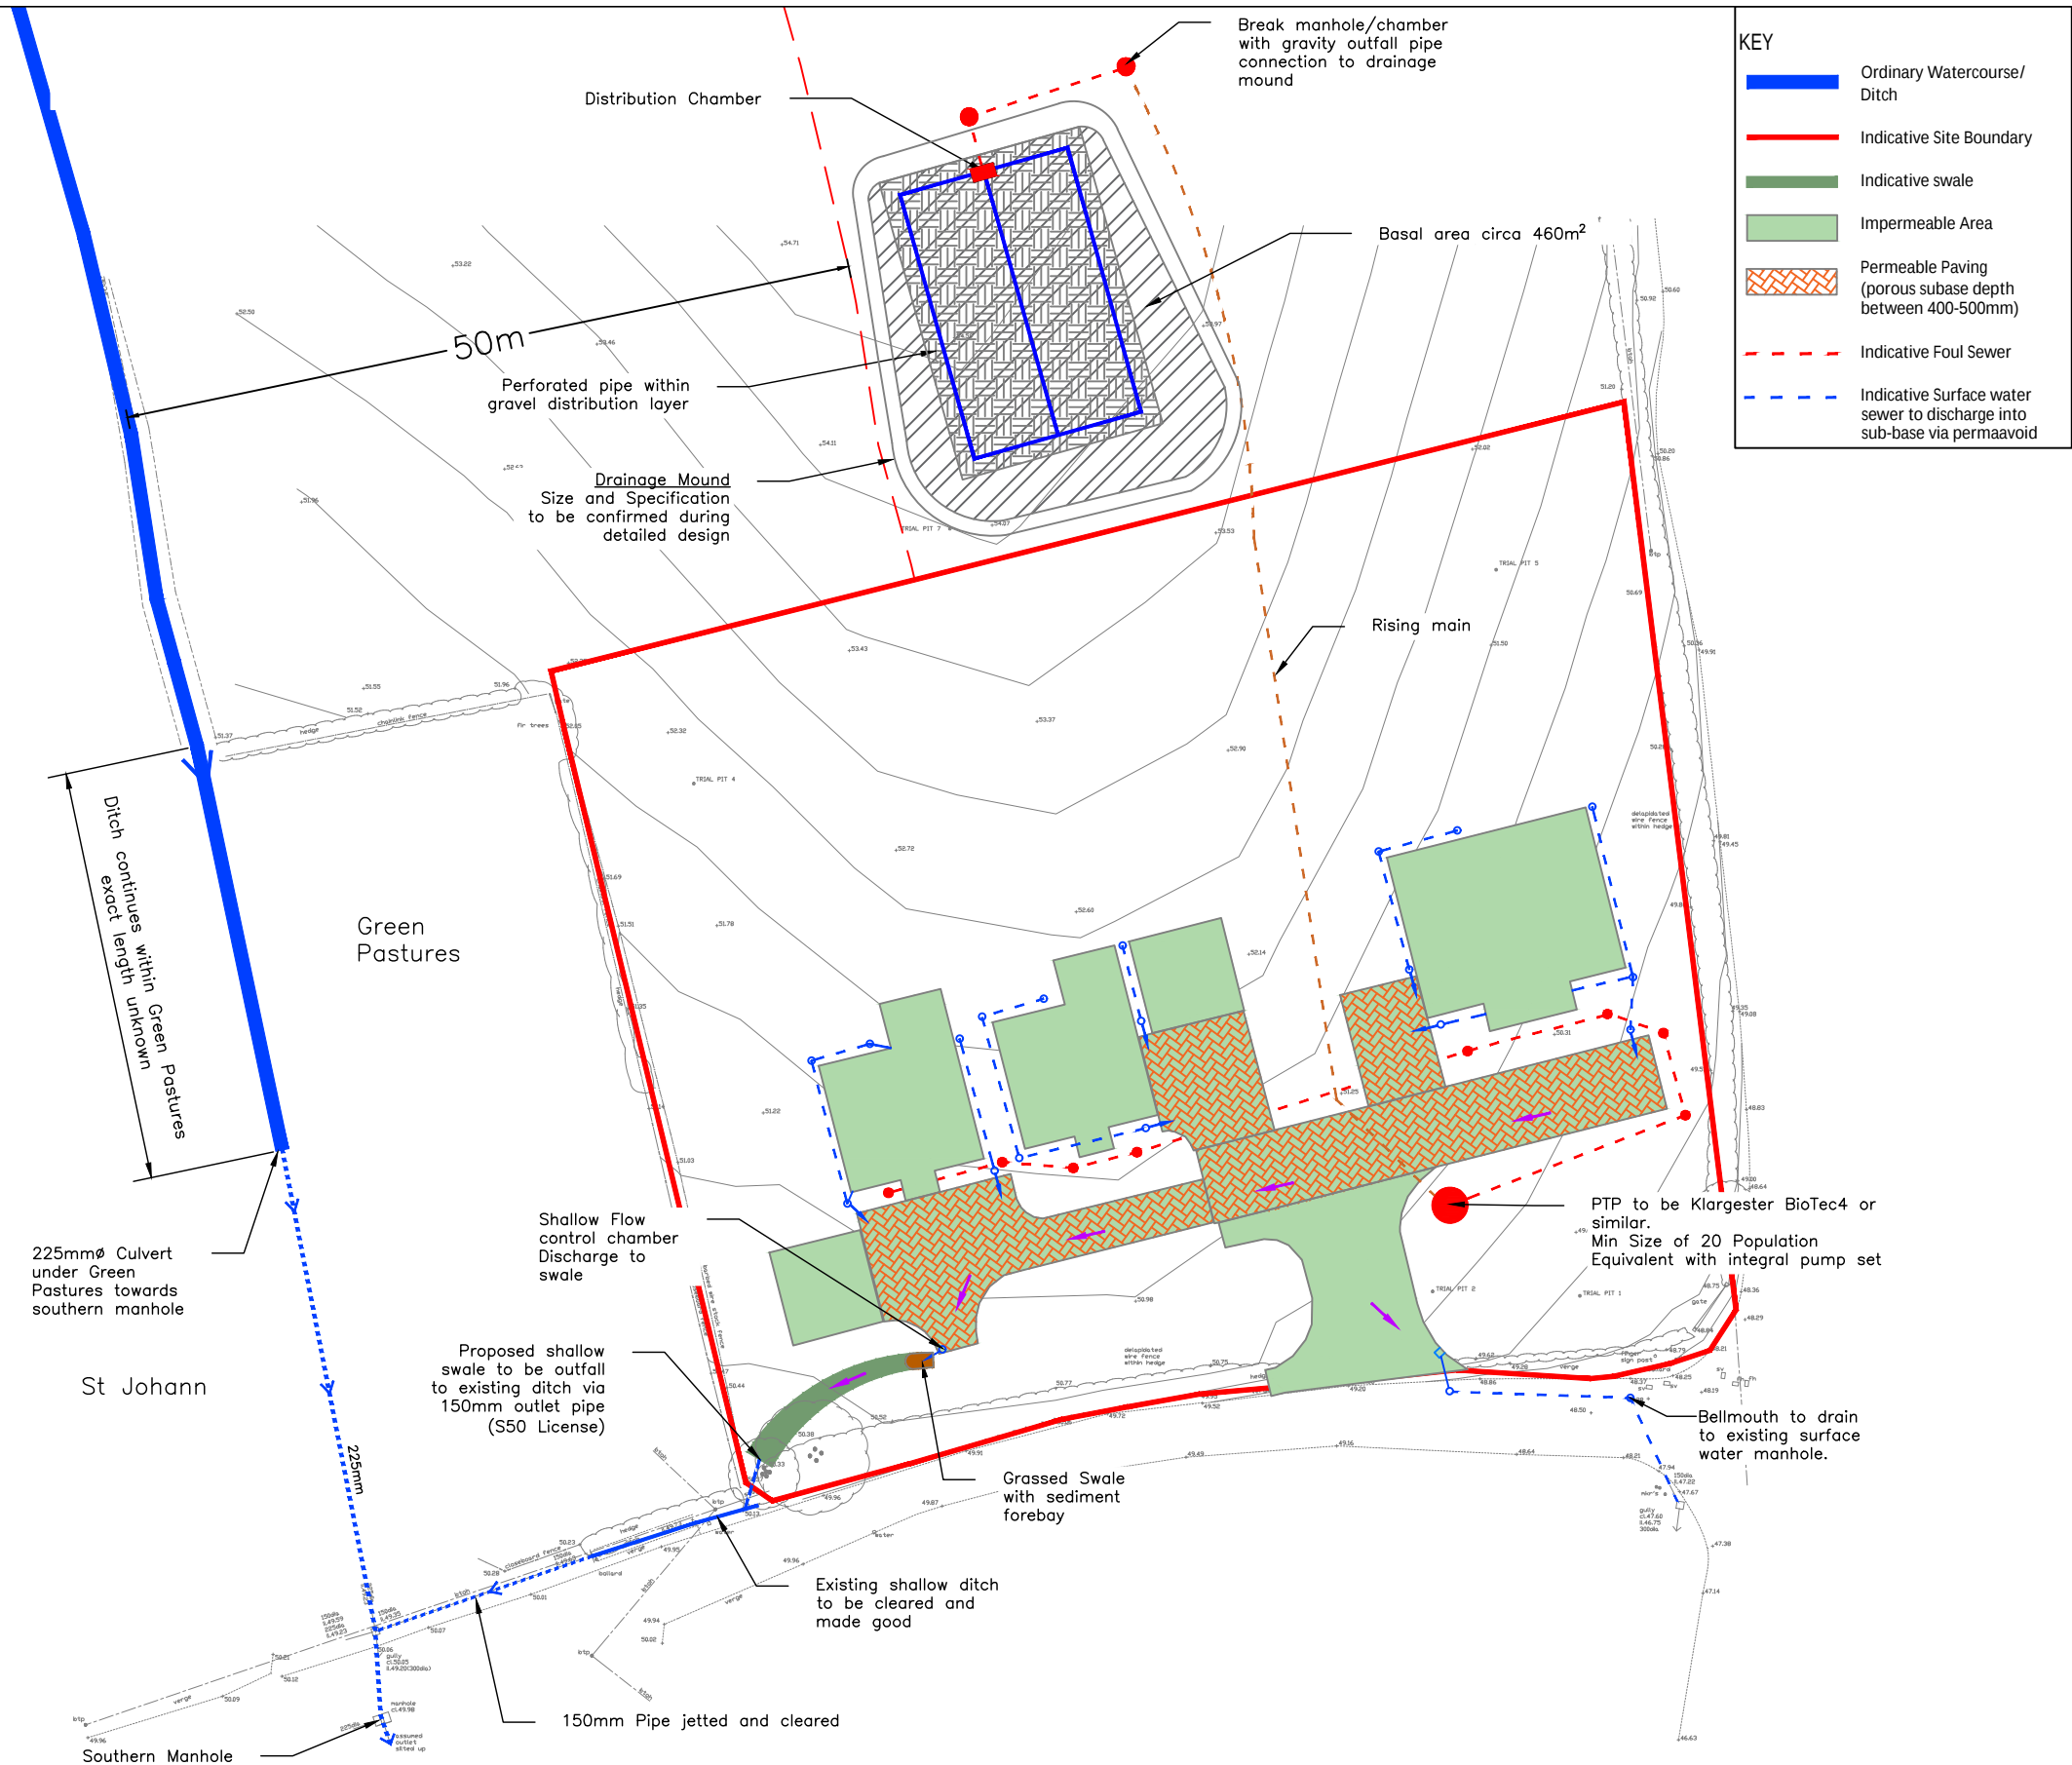

KEY	
	Ordinary Watercourse/Ditch
	Indicative Site Boundary
	Indicative swale
	Impermeable Area
	Permeable Paving (porous subbase depth between 400-500mm)
	Indicative Foul Sewer
	Indicative Surface water sewer to discharge into sub-base via permaavoid

PFA
consulting

Stratton Park House, Wanborough Road
Swindon, SN3 4HG

Telephone
01793 828000

Website
www.pfapl.com

- NOTES
1. This drawing is based on topographical Survey produced by Phil Warren dated 22/11/18, Project No 18-11-02. It is noted that the survey is to local grid.
 2. Impermeable areas obtained from Schematic Drainage Layout Drawing No02 produced by Phil warren , dated 20/02/19
 3. This drawing should be read in conjunction with the Drainage Strategy File Notes.

Rev	Date	Description	Drawn	Check
#	01/05/20	First Issue.	DAB	CI
A	16/10/20	Revised strategy following drainage comments	DAB	CI
B	21/10/20	Minor changes to text.	BDC	CI
C	15/12/20	Revised following site meeting	DAB	CI
D	14/05/21	Drainage mound revised following additional soils investigation	DAB	CI

Status	FOR INFORMATION	
Client	MF Freeman Ltd	
Project	Land of Coldwells Rd Munstone	
Drawing Title	Preliminary Drainage Strategy	
Drawing No.	F476/02	Rev D
Date:	May 2020	Scale: 1:500 @ A3
E-Mail:	Dbuciak@pfapl.com	

