


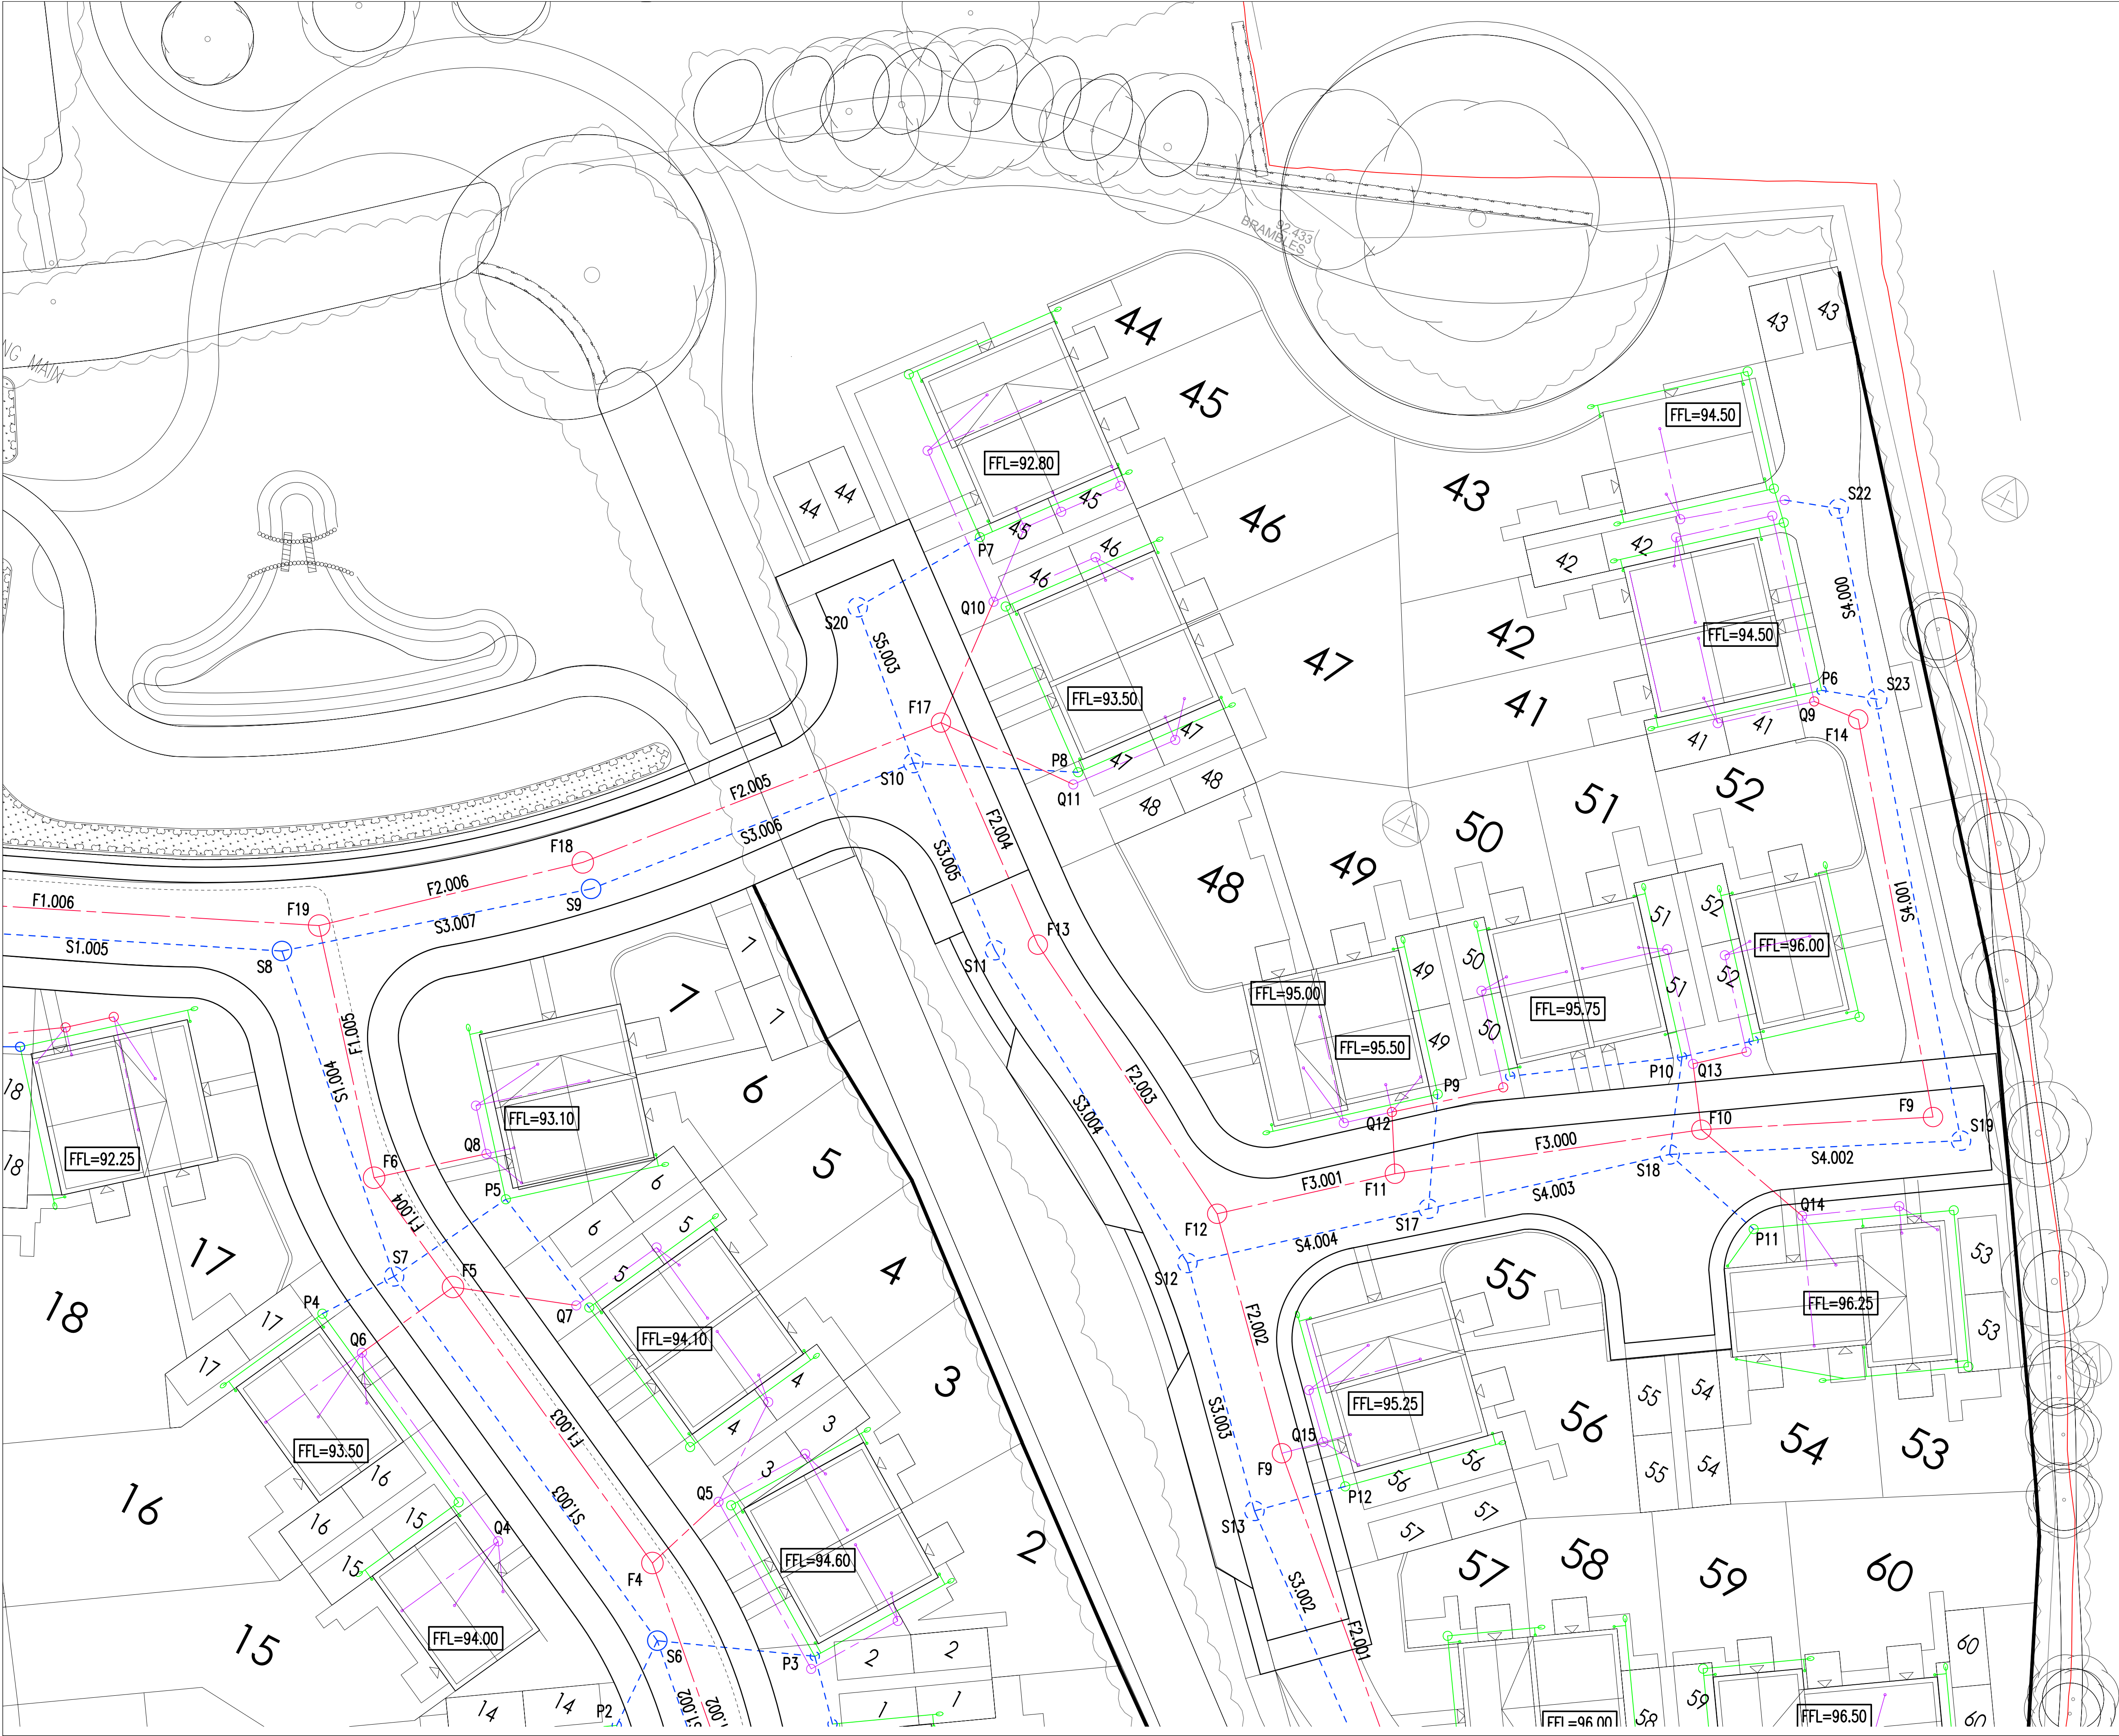

- NOTES
- GENERAL
1. ALL DIMENSIONS ARE IN MILLIMETRES UNLESS NOTED OTHERWISE.
 2. ALL LEVELS ARE IN METRES UNLESS NOTED OTHERWISE.
 3. ALL LEVELS RELATE TO ORDNANCE DATUM UNLESS NOTED OTHERWISE.
 4. DO NOT SCALE FROM THIS DRAWING. USE FIGURED DIMENSIONS ONLY.
 5. ANY DISCREPANCIES TO BE REPORTED IMMEDIATELY TO THE ENGINEER.
 6. THIS DRAWING TO BE READ IN CONJUNCTION WITH ALL RELEVANT ARCHITECTS, SUBCONTRACTORS AND SPECIALISTS DRAWINGS AND SPECIFICATIONS.
 7. THIS DRAWING IS COPYRIGHT © intrado robbins CONSULTING ENGINEERS.

B	UPDATED TO ARCHITECTS LATEST LAYOUT	BP	27/03/20
A	PIPE NUMBERS ADDED	CLC	26/9/19
REV.	DESCRIPTION	BY	DATE

intradorobbins
Consulting Engineers

CARDIFF OFFICE
Castle House, 63/69 Cardiff Road
Taffs Well, Cardiff, CF11 7ED
tel: 02920 811097 web: www.intrado.co.uk e-mail: admin@intrado.co.uk

SWANSEA OFFICE
20 Caswell Avenue, Caswell
Swansea, SA3 4RU

client **ENGIE**

project **LAND OFF MADLEY ROAD, CLEHONGER**

drawing title **DRAINAGE LAYOUT
SHEET 5**

drawn	ML	chkd	CLC	scale	1:200@A1	date	SEPT 2019
-------	----	------	-----	-------	----------	------	-----------

Preliminary	☒	Job No.	IR18065	Drawing No.	104	Rev.	B
Tender	☐						
Construction	☐						